



California Regional Water Quality Control Board  
Los Angeles Region



Linda S. Adams  
Agency Secretary

320 W. 4th Street, Suite 200, Los Angeles, California 90013  
Phone (213) 576-6600 FAX (213) 576-6640 - Internet Address: <http://www.waterboards.ca.gov/losangeles>

Arnold Schwarzenegger  
Governor

January 2, 2008

Mr. Allen Rosenstein  
P. O. Box 8237  
Northridge, CA 91327

**REVISION OF GENERAL WASTE DISCHARGE REQUIREMENTS FOR GROUNDWATER  
CLEANUP AT PETROLEUM HYDROCARBON FUEL, VOLATILE ORGANIC COMPOUND  
AND/OR HEXAVALENT CHROMIUM IMPACTED SITES  
AL ROSENSTEIN PROPERTY  
5570 MELROSE AVENUE, LOS ANGELES (ID #900380343)  
(ORDER NO. R4-2007-0019, SERIES NO. 027; CI NO. 9298)**

Dear Mr. Rosenstein:

Our letter dated September 18, 2007, transmitted the general waste discharge requirements (WDRs) for ozone injection at the subject site. On your behalf, your consultant, Lindmark Engineering (LE) sent us an e-mail dated November 30, 2007, on the relocation of injection well IW-1. Due to a buried telephone cable at the proposed well IW-1, LE proposes to move IW-1 approximately 12 inches east from the location (see attached revised site plan). In addition, LE requested to install one additional injection well IW-8 near Well GW-4 as benzene concentration in well GW-4 has increased significantly based on recent monitoring data.

We have reviewed the information provided and approve your proposal for a location change for IW-1 and the installation of IW-8, provided that you strictly comply with Order No. R-4-2007-0019 (Serial 027) including Monitoring and Reporting Program CI-9298.

If you have any questions concerning this matter, please call Dr. Weixing Tong at (213) 576-6715 or sent him an email at [wtong@waterboards.ca.gov](mailto:wtong@waterboards.ca.gov) or Mrs. Mercedes Hsu at (213) 576-6712 or e-mail her at [mhsu@waterboards.ca.gov](mailto:mhsu@waterboards.ca.gov).

 
Sincerely,

  
Tracy J. Egoscue  
Executive Officer


Enclosures


Cc: Ms. Yvonne Shanks, State Water Resources Control Board, Underground Storage Tank  
Cleanup Fund  
Capt. Frank Comfort, Los Angeles City Fire Department, Underground Tanks  
Ms. Valerie Toney, Los Angeles City Fire Department, Underground Tanks  
Mr. Philip Mihopoulos, Lindmark Engineering

*California Environmental Protection Agency*



 *Our mission is to preserve and enhance the quality of California's water resources for the benefit of present and future generations.*

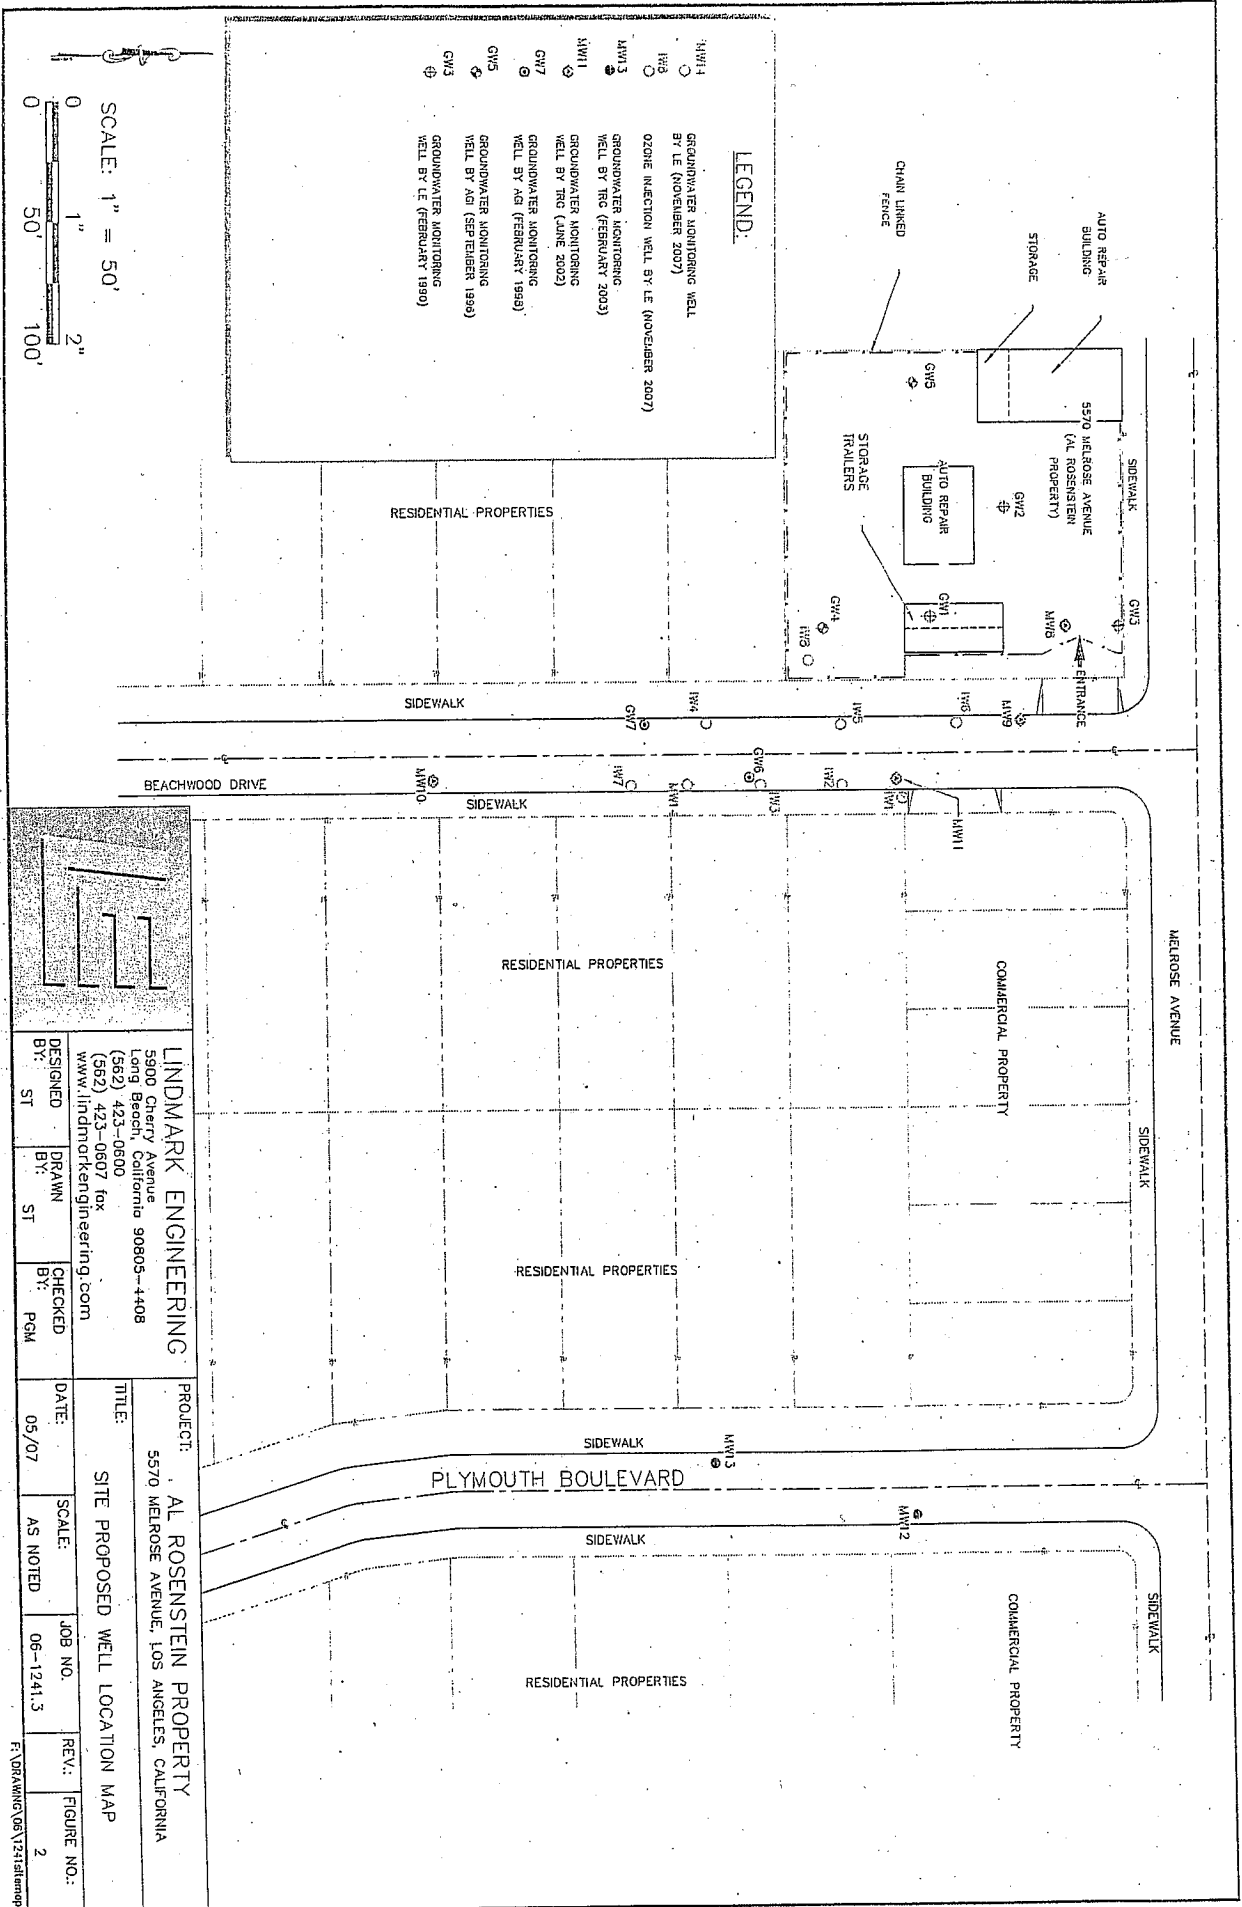

			<b>LINDMARK ENGINEERING</b> 5900 Cherry Avenue Long Beach, California 90805-4408 (562) 423-0800 www.lindmarkengineering.com		
DESIGNED	BY: ST	DRAWN	BY: ST	CHECKED	BY: PGM
DATE:	05/07	SCALE:	AS NOTED	JOB NO.:	06-1241.3
PROJECT:	AL ROSENSTEIN PROPERTY				
TITLE:	SITE PROPOSED WELL LOCATION MAP				
REV:	FIGURE NO.: 2				

F:\DRAWING\06\1241stemp